

GENERAL NOTES

- A. FOR LOCATION OF SUMMER WALLS AND SUPPORTS, REFER TO REFLECTED CEILING PLAN.
- B. FOR FLOOR ELEVATIONS, SEE SLAB PLAN.
- C. SCHEDULE OF CONCRETE CURBS, SEE SLAB PLAN.
- D. GROUND DIMENSIONS ON THIS FLOOR PLAN SHALL BE LOCATED BY "FROM FINISHED CLEAR WALL L.I.N.E."
- E. ALL FINISHED WALL DIMENSIONS ARE TO FACE UNLESS NOTED OTHERWISE.
- F. ALL DIMENSIONS ARE TO FACE UNLESS NOTED OTHERWISE.
- G. ALL DIMENSIONS ARE TO FACE UNLESS NOTED OTHERWISE.
- H. INCLUDE 1/2" OF RISE IN WOODS FINISHING DETAIL STAIR BLOODINGS AT ALL ELEVATIONS, SINKS, & SHELVE LOCATIONS, SEE S.E. & S.F. FOR DETAILS.
- I. PROVIDE 1/2" OF RISE IN WOODS FINISHING DETAIL STAIR BLOODINGS AT ALL ELEVATIONS, SINKS, & SHELVE LOCATIONS, SEE S.E. & S.F. FOR DETAILS.
- J. PROVIDE 1/2" OF RISE IN WOODS FINISHING DETAIL STAIR BLOODINGS AT ALL ELEVATIONS, SINKS, & SHELVE LOCATIONS, SEE S.E. & S.F. FOR DETAILS.
- K. PROVIDE 1/2" OF RISE IN WOODS FINISHING DETAIL STAIR BLOODINGS AT ALL ELEVATIONS, SINKS, & SHELVE LOCATIONS, SEE S.E. & S.F. FOR DETAILS.
- L. PROVIDE 1/2" OF RISE IN WOODS FINISHING DETAIL STAIR BLOODINGS AT ALL ELEVATIONS, SINKS, & SHELVE LOCATIONS, SEE S.E. & S.F. FOR DETAILS.
- M. PROVIDE 1/2" OF RISE IN WOODS FINISHING DETAIL STAIR BLOODINGS AT ALL ELEVATIONS, SINKS, & SHELVE LOCATIONS, SEE S.E. & S.F. FOR DETAILS.
- N. PROVIDE 1/2" OF RISE IN WOODS FINISHING DETAIL STAIR BLOODINGS AT ALL ELEVATIONS, SINKS, & SHELVE LOCATIONS, SEE S.E. & S.F. FOR DETAILS.
- O. PROVIDE 1/2" OF RISE IN WOODS FINISHING DETAIL STAIR BLOODINGS AT ALL ELEVATIONS, SINKS, & SHELVE LOCATIONS, SEE S.E. & S.F. FOR DETAILS.
- P. PROVIDE 1/2" OF RISE IN WOODS FINISHING DETAIL STAIR BLOODINGS AT ALL ELEVATIONS, SINKS, & SHELVE LOCATIONS, SEE S.E. & S.F. FOR DETAILS.
- Q. PROVIDE 1/2" OF RISE IN WOODS FINISHING DETAIL STAIR BLOODINGS AT ALL ELEVATIONS, SINKS, & SHELVE LOCATIONS, SEE S.E. & S.F. FOR DETAILS.
- R. PROVIDE 1/2" OF RISE IN WOODS FINISHING DETAIL STAIR BLOODINGS AT ALL ELEVATIONS, SINKS, & SHELVE LOCATIONS, SEE S.E. & S.F. FOR DETAILS.
- S. PROVIDE 1/2" OF RISE IN WOODS FINISHING DETAIL STAIR BLOODINGS AT ALL ELEVATIONS, SINKS, & SHELVE LOCATIONS, SEE S.E. & S.F. FOR DETAILS.
- T. PROVIDE 1/2" OF RISE IN WOODS FINISHING DETAIL STAIR BLOODINGS AT ALL ELEVATIONS, SINKS, & SHELVE LOCATIONS, SEE S.E. & S.F. FOR DETAILS.
- U. PROVIDE 1/2" OF RISE IN WOODS FINISHING DETAIL STAIR BLOODINGS AT ALL ELEVATIONS, SINKS, & SHELVE LOCATIONS, SEE S.E. & S.F. FOR DETAILS.
- V. VERIFY DIMENSIONS OF ALL FIXTURES & EQUIPMENT FROM EQUIPMENT BINDER PROVIDED BY CLIENTS. PROVIDE & VERIFY DIMENSIONS AGAINST THE INSTALLATION.
- W. VERIFY DIMENSIONS OF ALL FIXTURES & EQUIPMENT FROM EQUIPMENT BINDER PROVIDED BY CLIENTS. PROVIDE & VERIFY DIMENSIONS AGAINST THE INSTALLATION.
- X. VERIFY DIMENSIONS OF ALL FIXTURES & EQUIPMENT FROM EQUIPMENT BINDER PROVIDED BY CLIENTS. PROVIDE & VERIFY DIMENSIONS AGAINST THE INSTALLATION.
- Y. VERIFY DIMENSIONS OF ALL FIXTURES & EQUIPMENT FROM EQUIPMENT BINDER PROVIDED BY CLIENTS. PROVIDE & VERIFY DIMENSIONS AGAINST THE INSTALLATION.
- Z. VERIFY DIMENSIONS OF ALL FIXTURES & EQUIPMENT FROM EQUIPMENT BINDER PROVIDED BY CLIENTS. PROVIDE & VERIFY DIMENSIONS AGAINST THE INSTALLATION.

LEGEND

- ◆ SHIELD TAG
- ◆ INDICATES WALL DETAIL, SEE A-7
- ◆ INDICATES METAL STUD WALL, SEE W-100



DATE	ISSUE
11/20/20	ISSUE FOR PERMIT
11/20/20	ISSUE FOR PERMIT



Heights Ventures
ARCHITECTS & ENGINEERS

FIESTA FOODSTORE LEWISVILLE

724 W. MAIN STREET
LEWISVILLE, TX 75067

Project Name: Fiesta Foodstore
 Project No: 23002-001-000
 Date: 09/20/2022
 Scale: AS SHOWN
 Drawn By: WJ/KL
 Checked By: WJ/KL
 Project Manager: WJ/KL

DIMENSION CONTROL PLAN

A1.0a






DATE	ISSUE
10/2/2022	ISSUE FOR PERMIT
11/2/2022	ISSUE FOR BID

- KEYED NOTES**
1. ALL TELEPHONE TERMINAL BOARDS CONTRACTOR TO INTERCEPT AND EXTEND EXISTING TELEPHONE DATA SERVICES TO THE TELEPHONE TERMINAL BOARDS.
 2. CONTRACTOR SHALL INSTALL 1/2" MTL-GRADE FOR FIRE SUPPRESSION VALVE SUPERBODY PARTICLE COORDINATE WITH FIRE ALARM CONTRACTOR FOR SPECIFIC LOCATIONS AND SCOPE.
 3. IN FLOOR DUCT SYSTEMS IS SHOWN FOR INFORMATION ONLY.
 4. PROVIDE 3/4" Ø WITH FULL STRIP TO FLOOR FOR ROOF WATCH MONITORING AND ALARM.
 5. PROVIDE 3/4" Ø WITH FULL STRIP TO FLOOR FOR ROOF WATCH MONITORING AND ALARM.
 6. THIS PANEL - (D) PHONE LINES FROM MPOE. (G) PHONE LINES FROM MFC.
 7. WALL MOUNT RACK, SUPPLIED BY OTHERS.

- SYMBOL LIST**
- ▼ DATA LINE-CAT5/R45 JACK
 - ▼ TELEPHONE DATA COMBO LOCATION 1/2" A.F.F. UNLS.
 - ▼ TELEPHONE LINE-CAT5/R45 JACK UNLS.
 - TELEPHONE OUTLET LOCATED AT 9/16" A.F.F. UNLS. OVER ROOF SYSTEMS.
 - PROVIDE DATA AT ALL TV LOCATIONS (NOT SHOWN ON THESE PLANS) THE RED CIRCLE LOCATIONS OF TV'S WITH POWER PLANS BEING ORDERED.
 - CITY CAMERA:
 - A- CAMERA SUSPENDED FROM STRUCTURE
 - B- CAMERA SURFACE MOUNTED TO WALL
 - C- CAMERA MOUNTED TO CEILING
- NOTE: CONTRACTOR TO VERIFY EXACT REQUIREMENTS AND LOCATION OF LIFE.

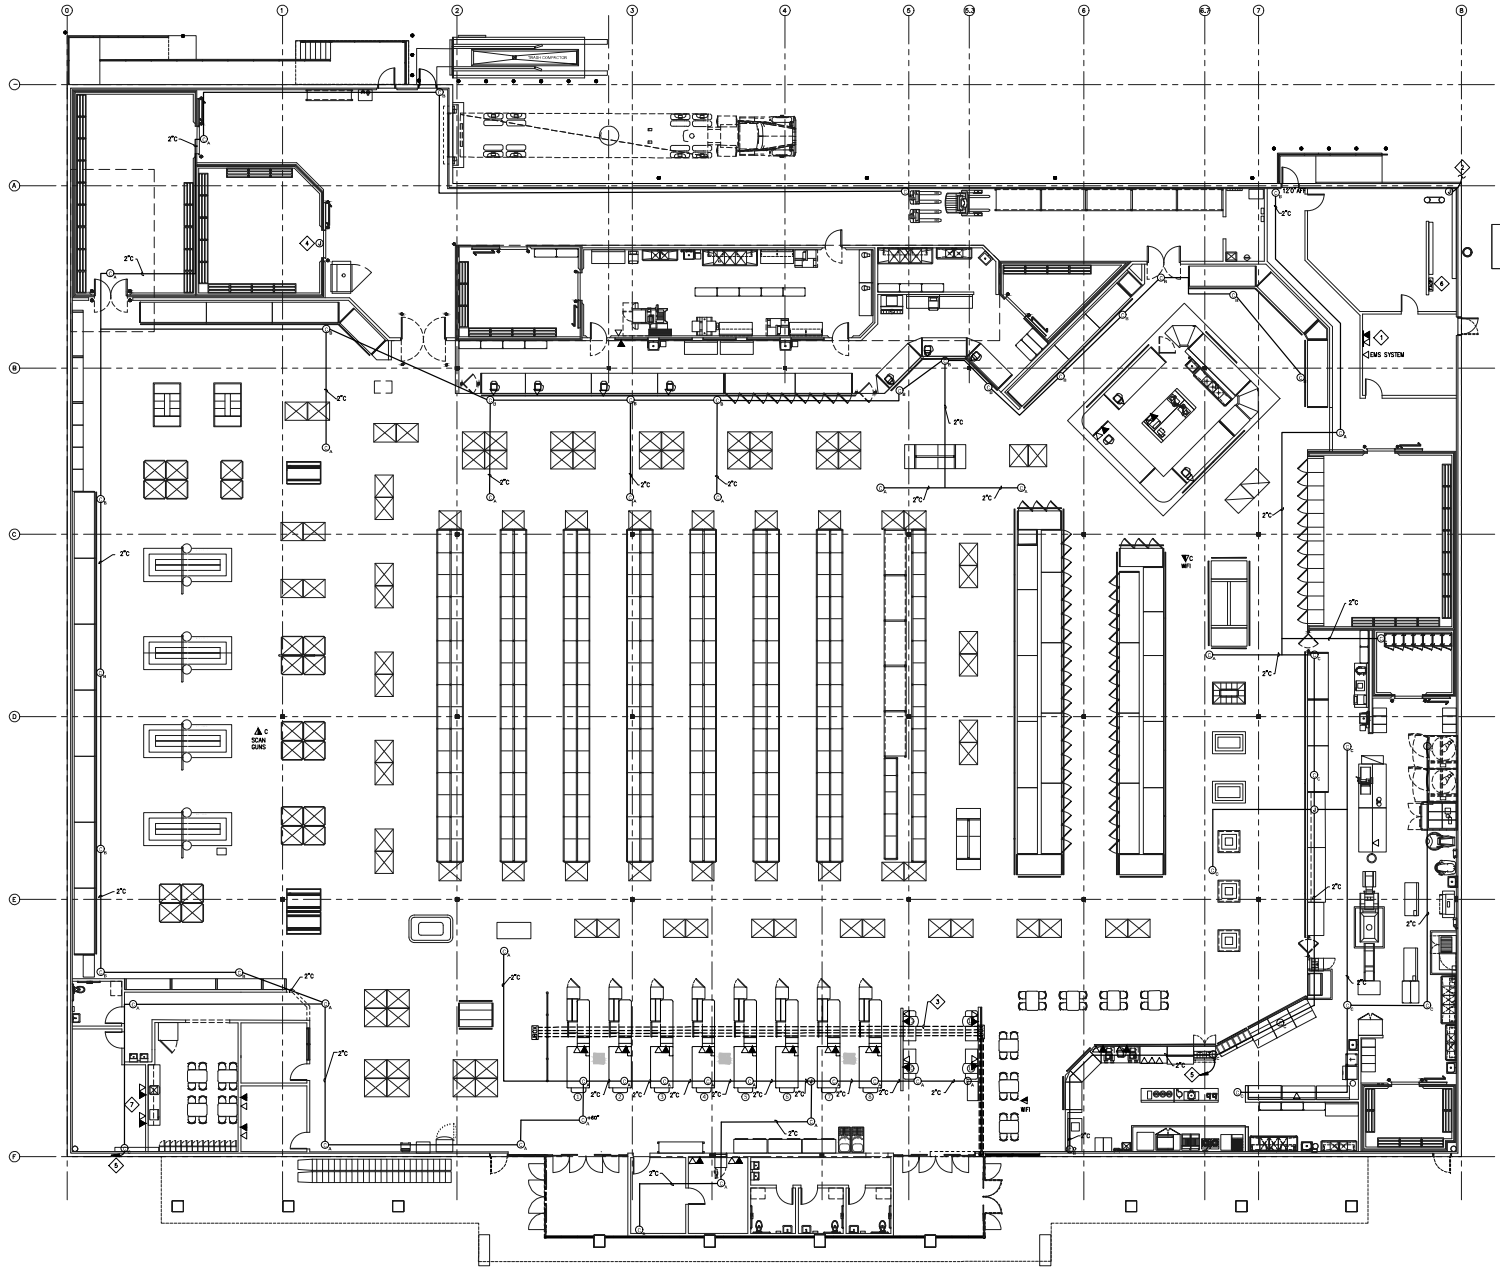

FIESTA FOODSTORE LEWISVILLE

724 W. MAIN STREET
LEWISVILLE, TX 75057

Project No: 23042-001-000
Date: 09/20/2022
Scale: AS SHOWN
Author: JG
Checked: WJ/KL
Project: PRODUCTION

SPECIAL SYSTEMS FLOOR PLAN

E3.3